 

 

 







 
 
 

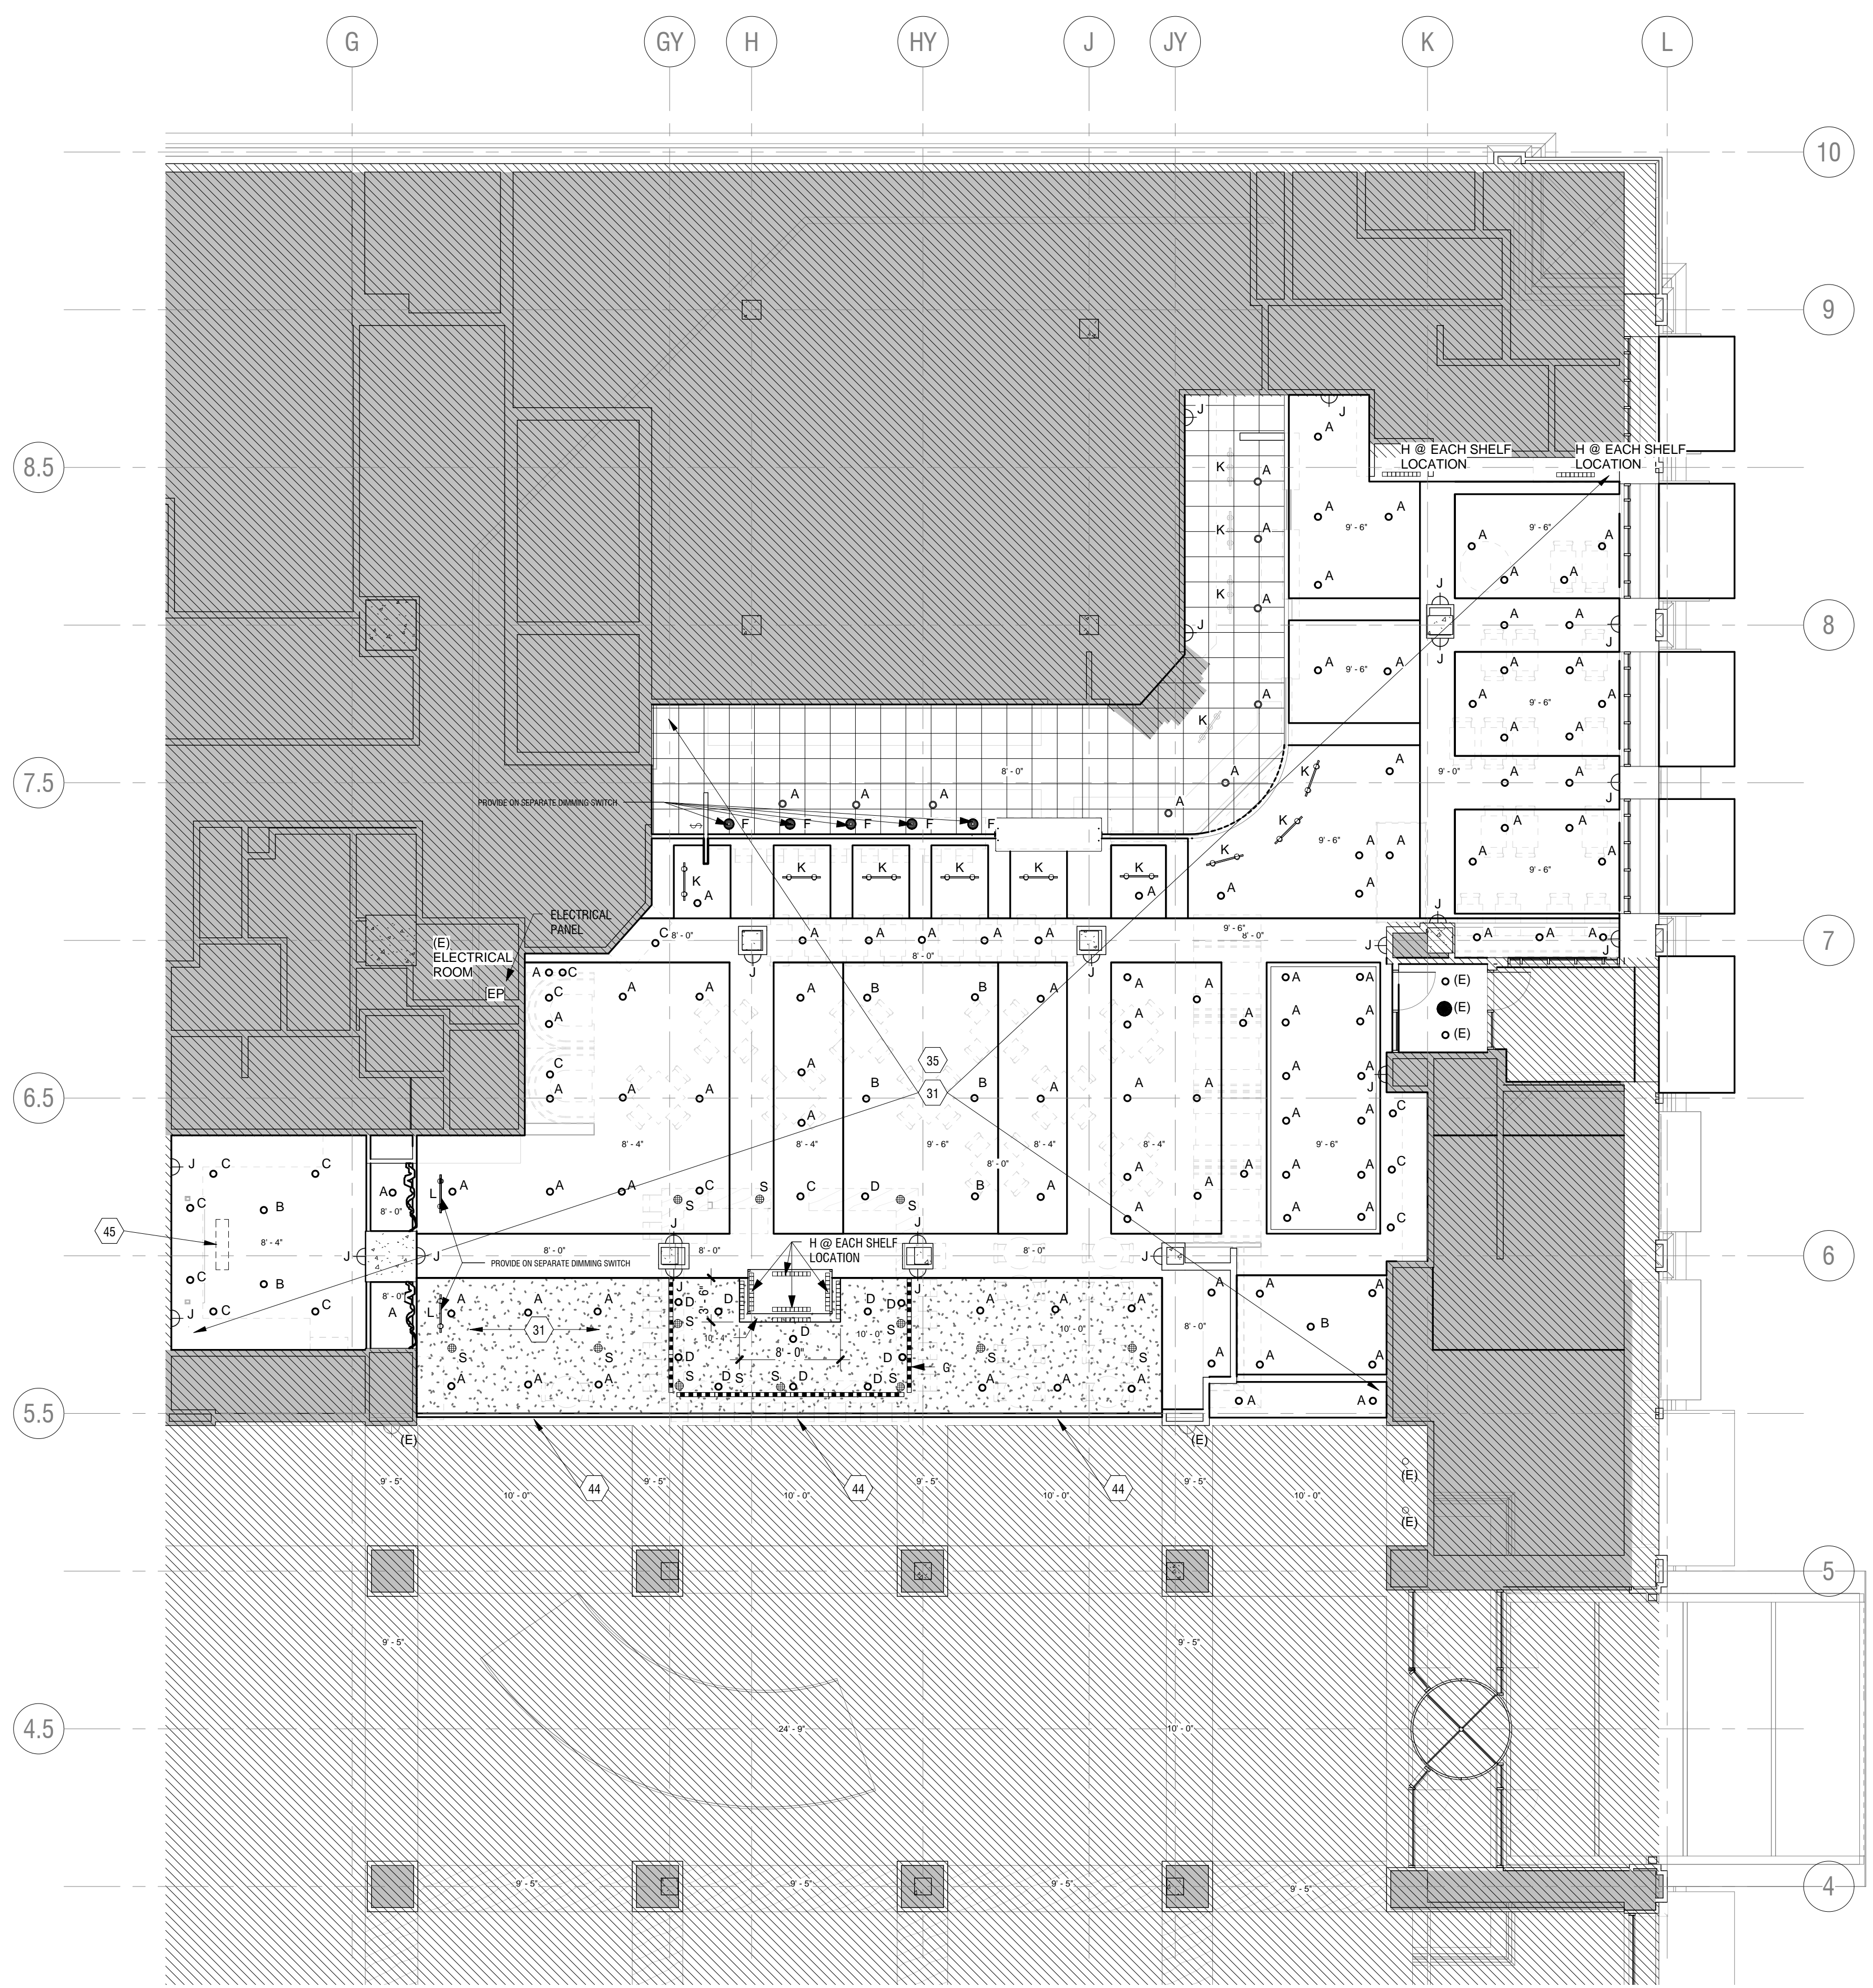


LEGEND - RCP

- | | | | |
|--|---|---|---|
|  | NEW WHITE VINYL CEILING TILES IN EXISTING CEILING GRID. COMMERCIAL GRADE FINISH FOR KITCHEN AREAS. CLEAN/REPAIR EXISTING GRID STRUCTURE AS NECESSARY. |  | NEW RECESSED LED 6" CAN IN EXISTING LIGHTING LOCATION. PATCH SHEETROCK AS NECESSARY. |
|  | NEW SUSPENDED GYPSUM BOARD CEILING - LEVEL 4 FINISH. PROVIDE GYP. SOFFIT RETURN TO TIE IN WITH EXISTING DROP CEILING. |  | NEW RECESSED LED 6" CAN IN NEW LOCATION. CUT & PATCH SHEETROCK AS NECESSARY. |
|  | CEILING TAG - CEILING HEIGHT RELATIVE TO FINISH FLOOR |  | NEW DIRECTIONAL RECESSED LED 6" CAN IN EXISTING LIGHTING LOCATION. PATCH SHEETROCK AS NECESSARY. |
|  | NEW LIGHTING CONTROLS IN EXISTING SWITCH PANEL LOCATION. PROVIDE NEW ZONAL / DIMMING CONTROL SYSTEM IN ELECTRICAL ROOM. |  | NEW DIRECTIONAL RECESSED LED 6" CAN IN NEW LOCATION. PATCH SHEETROCK AS NECESSARY. |
|  | ELECTRICAL PANEL | (E) | EXISTING LIGHTING TO REMAIN |
|  | NEW SPEAKER IN NEW LOCATION. PROVIDE CONNECTION TO EXISTING AUDIO EQUIPMENT AND TV'S LOCATED AT BAR. |  | SCHOOLHOUSE ELECTRIC 8" SHADE - ISAAC 1 PENDANT LIGHT, BLACK FINISH, BLACK CORD. PROVIDE ON SEPARATE DIMMER SWITCH |
| | |  | LED UNDER-COUNTER LED STRIP LIGHT |
| | |  | LED UNDER-SHELF LED STRIP LIGHT |
| | |  | NEW WALL SCONCE IN EXISTING LIGHTING LOCATION - PROGRESS LIGHTING CYLINDER P0675-31 (OR EQUIV.), 5" DIA. BLACK FINISH |
| | |  | NEW LED TRACK LIGHT IN EXISTING LIGHTING LOCATION |
| | |  | NEW LED TRACK LIGHT IN NEW LOCATION. PROVIDE ON SEPARATE DIMMER SWITCH |



PROPOSED REFLECTED CEILING PLAN 1
1/8" = 1'-0"

Project Location
Hilton Market
921 SW 6th Ave.
Portland, OR 97204



THESE DRAWINGS ARE FOR CONSTRUCTION BY JEAN-PIERRE VEILLET SITEWORKS, INC. ONLY

Date: 2014.12.08

Lead Designer: JEAN-PIERRE VEILLET

Architect: JESSAMYN GRIFFIN

Drawn By: DSM / JPM

Phase: CONSTRUCTION

Revisions:

#	Description	Date

Sheet Name
REFLECTED CEILING PLAN

Sheet No.

A201